


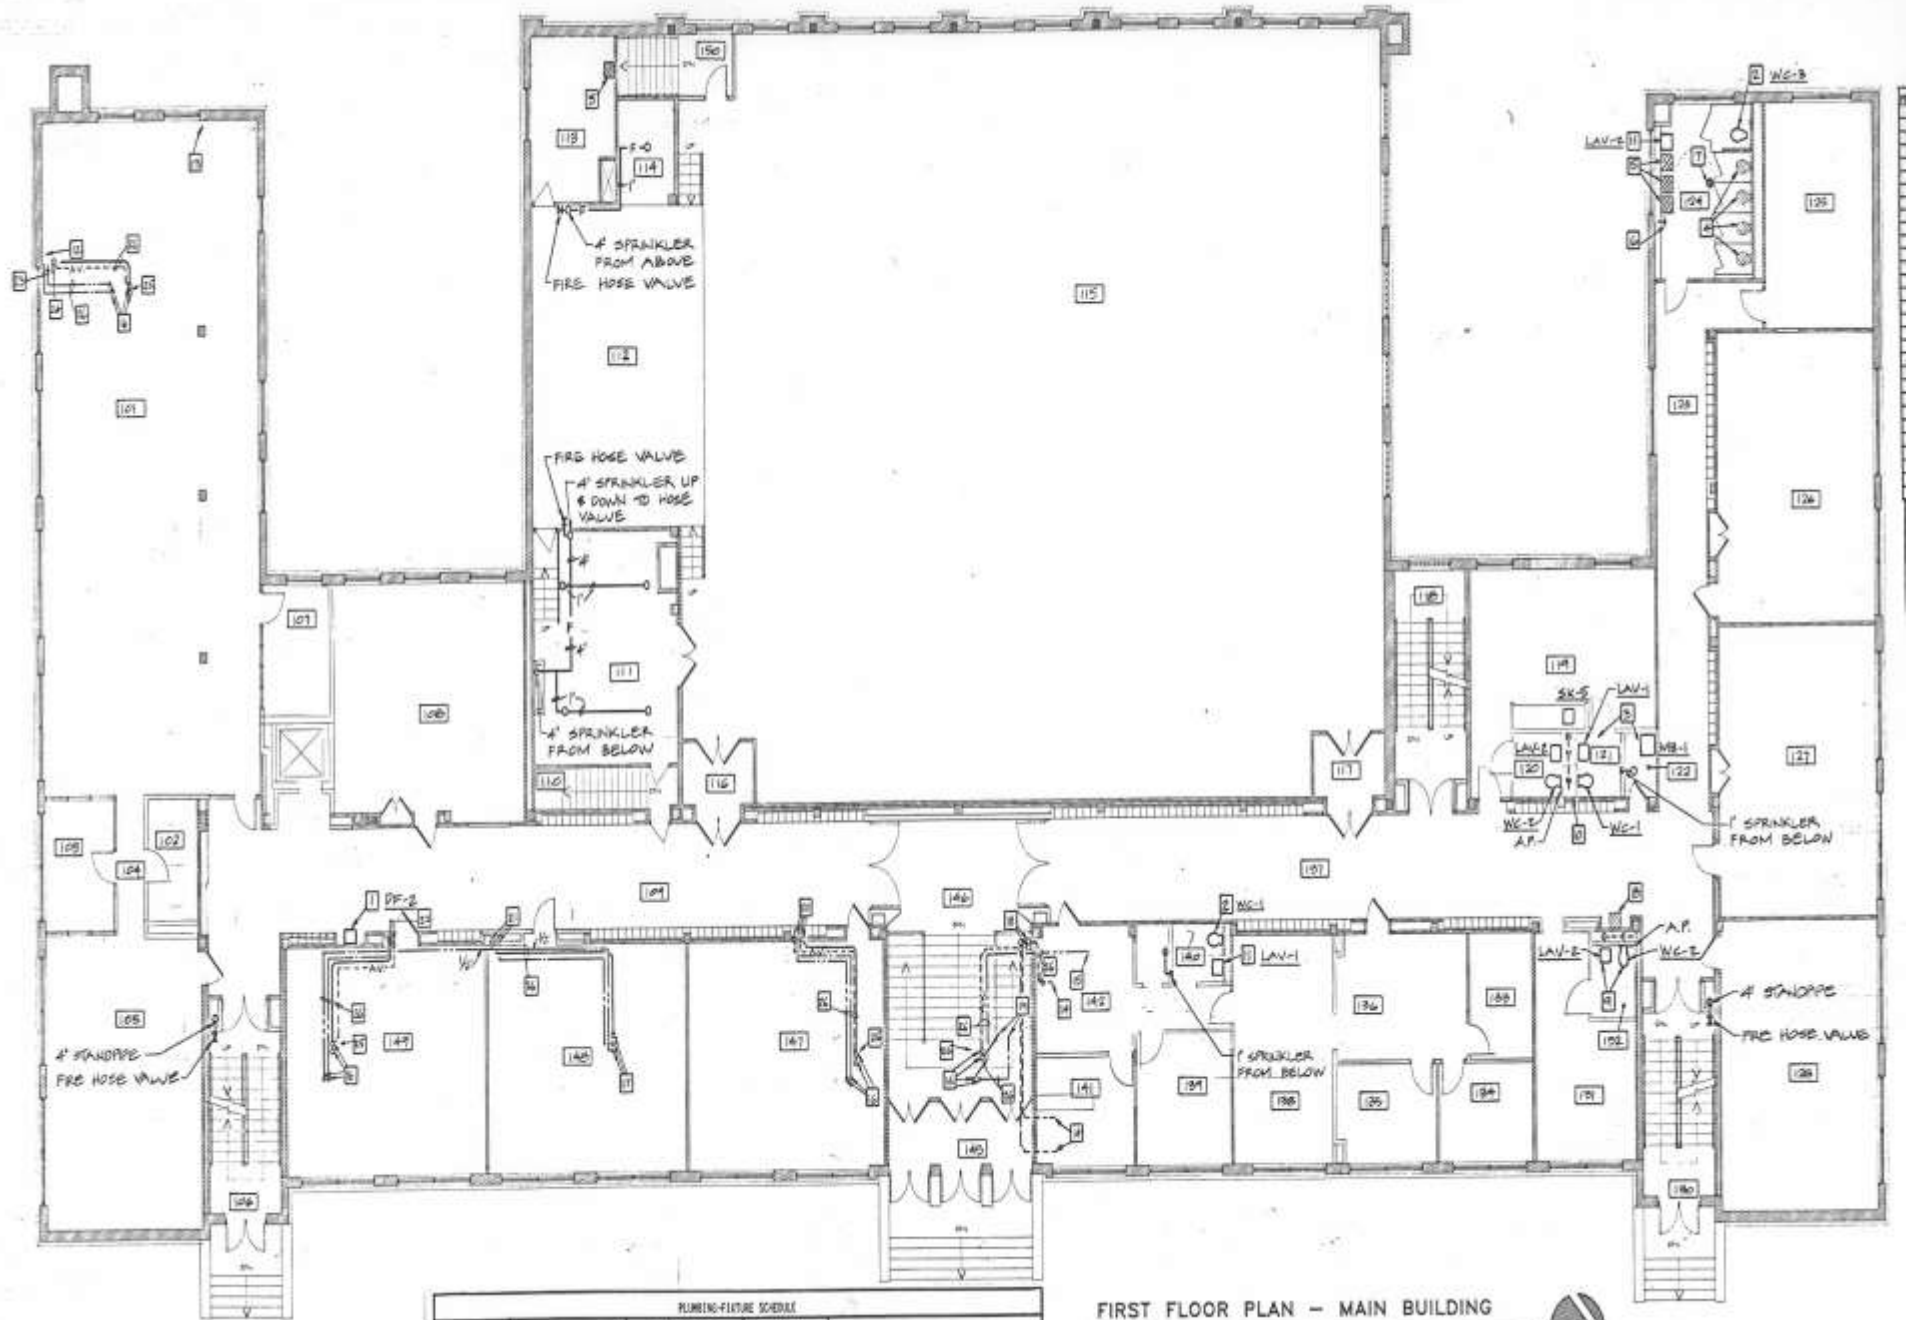


PLUMBING-FEATURE SCHEDULE				
NO.	UNIT & NO. NO.	NAME/FACET MAKE & MODEL	INSTALLING HEIGHT	REMARKS


FIRST FLOOR PLAN - MAIN BUILDING

SCALE: 1/8"=1'-0"



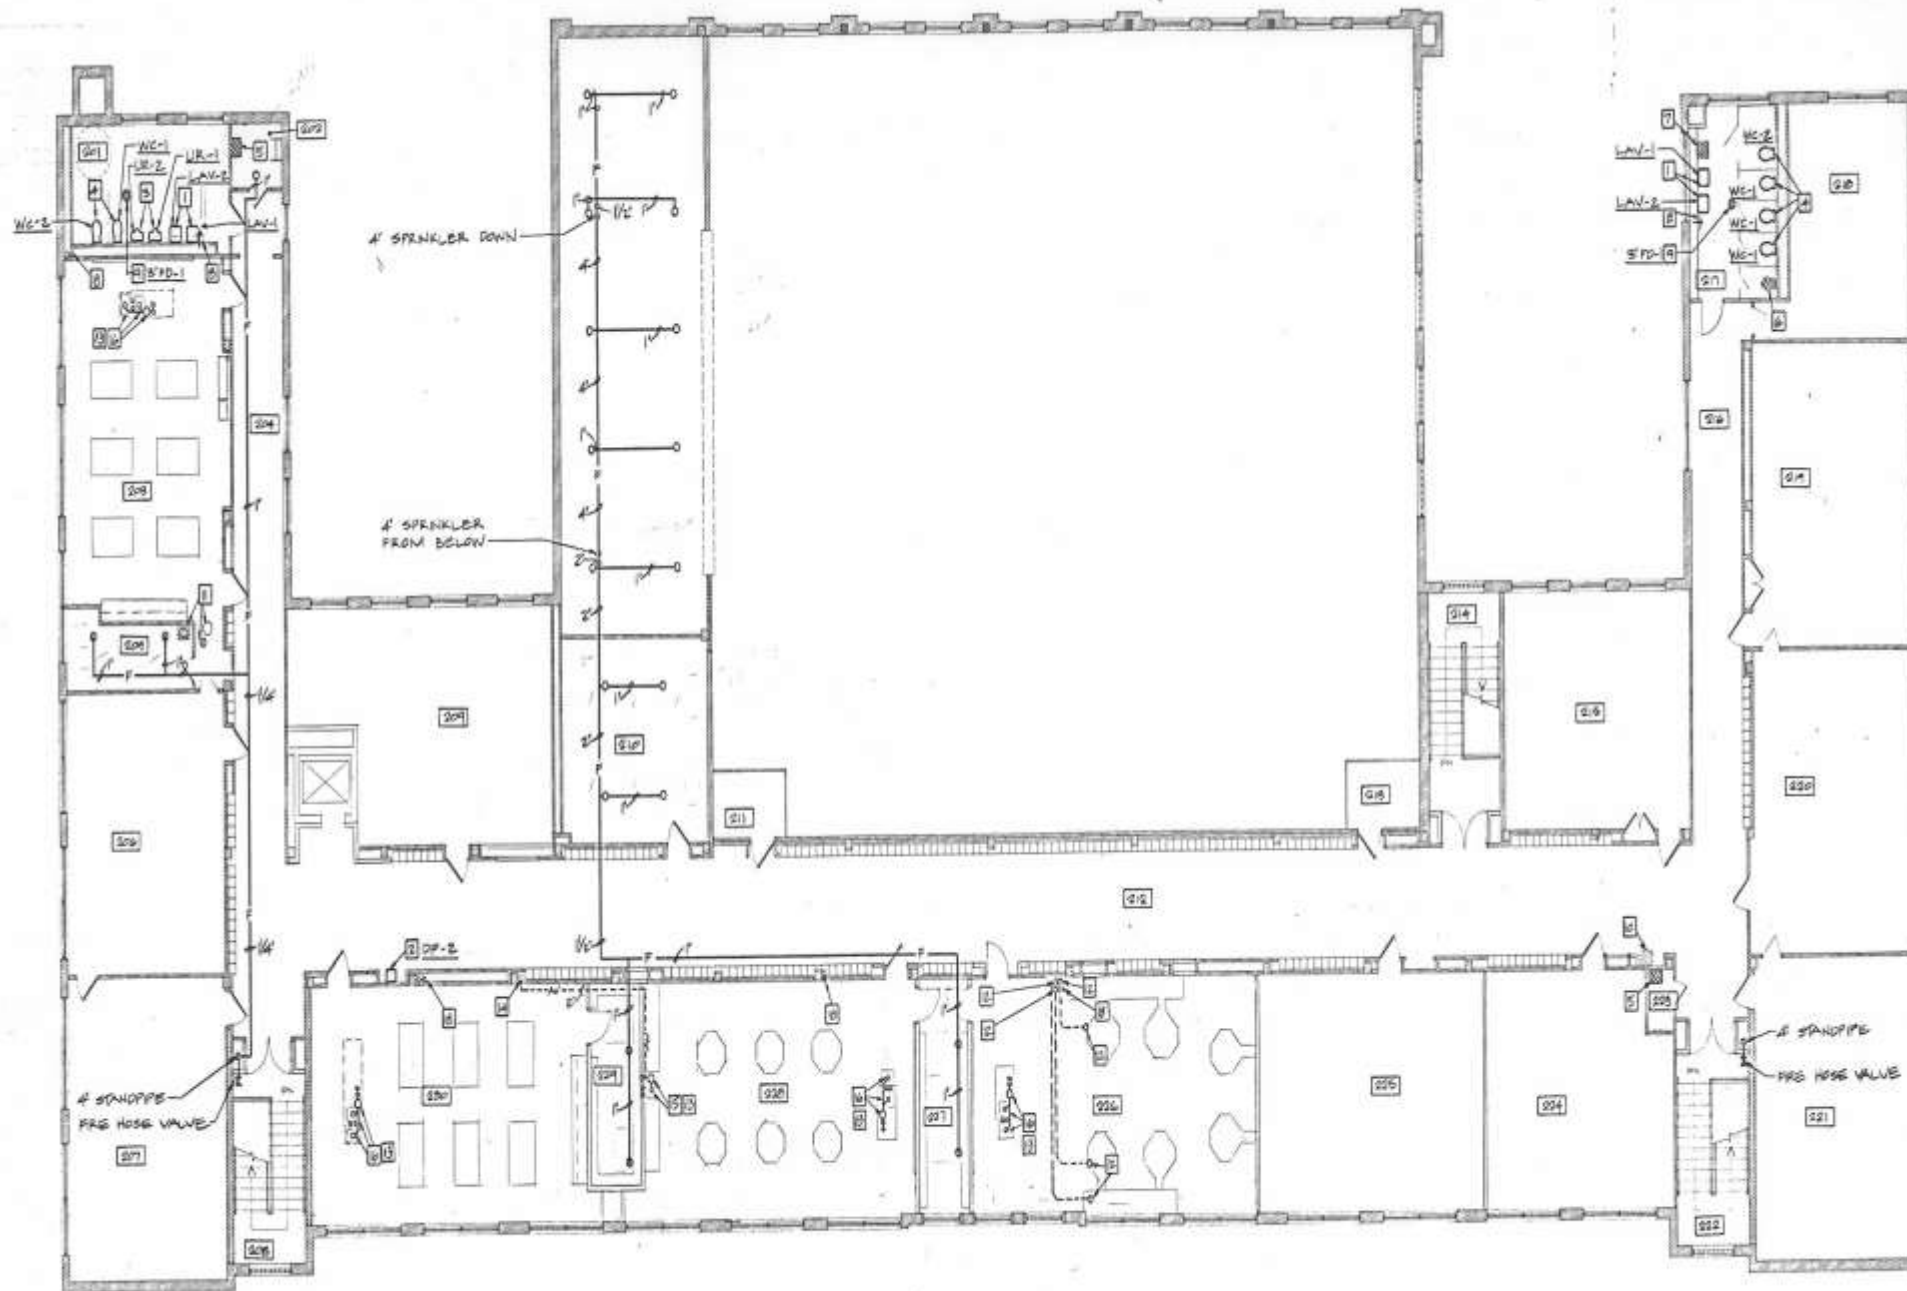


SECOND FLOOR PLAN - MAIN BUILDING

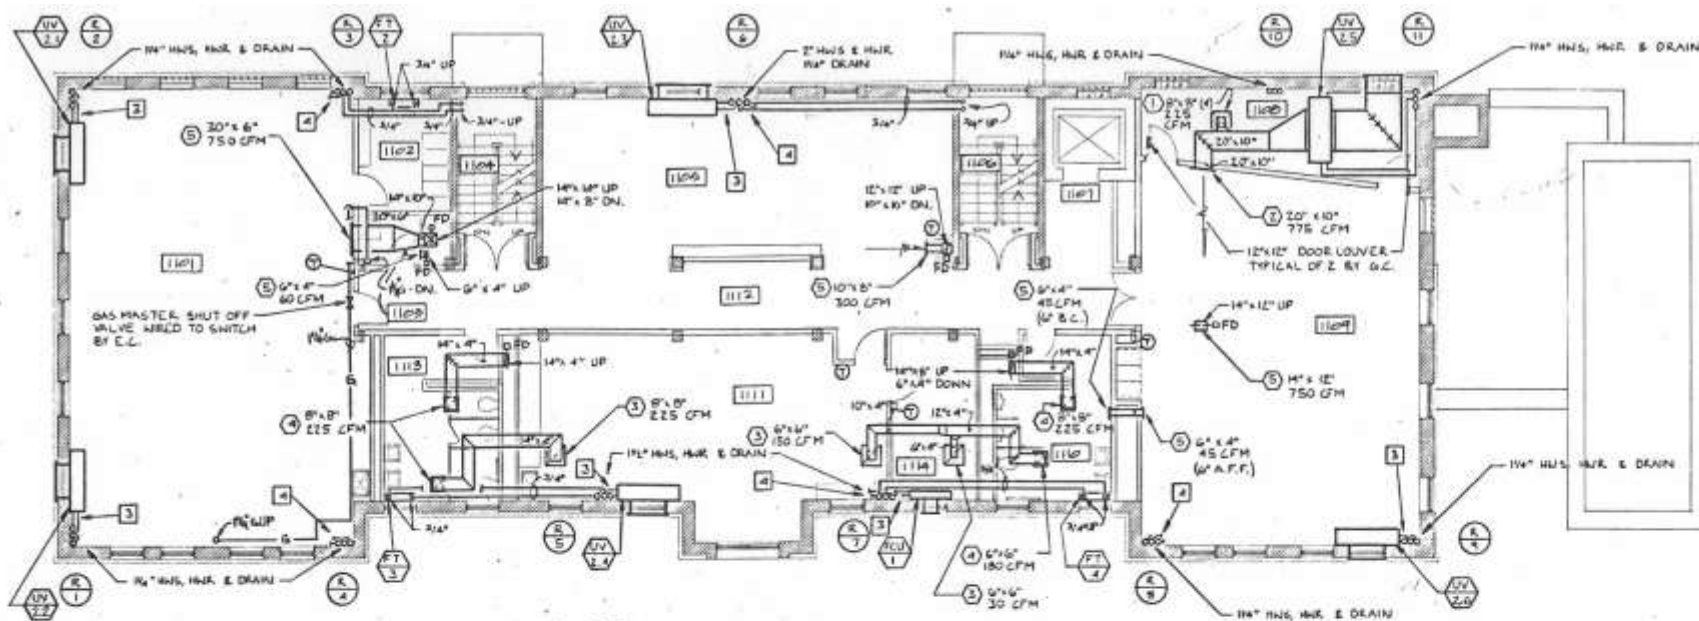

FIRST FLOOR PLAN - ANNEX

SCALE: 1/8"=1'-0"

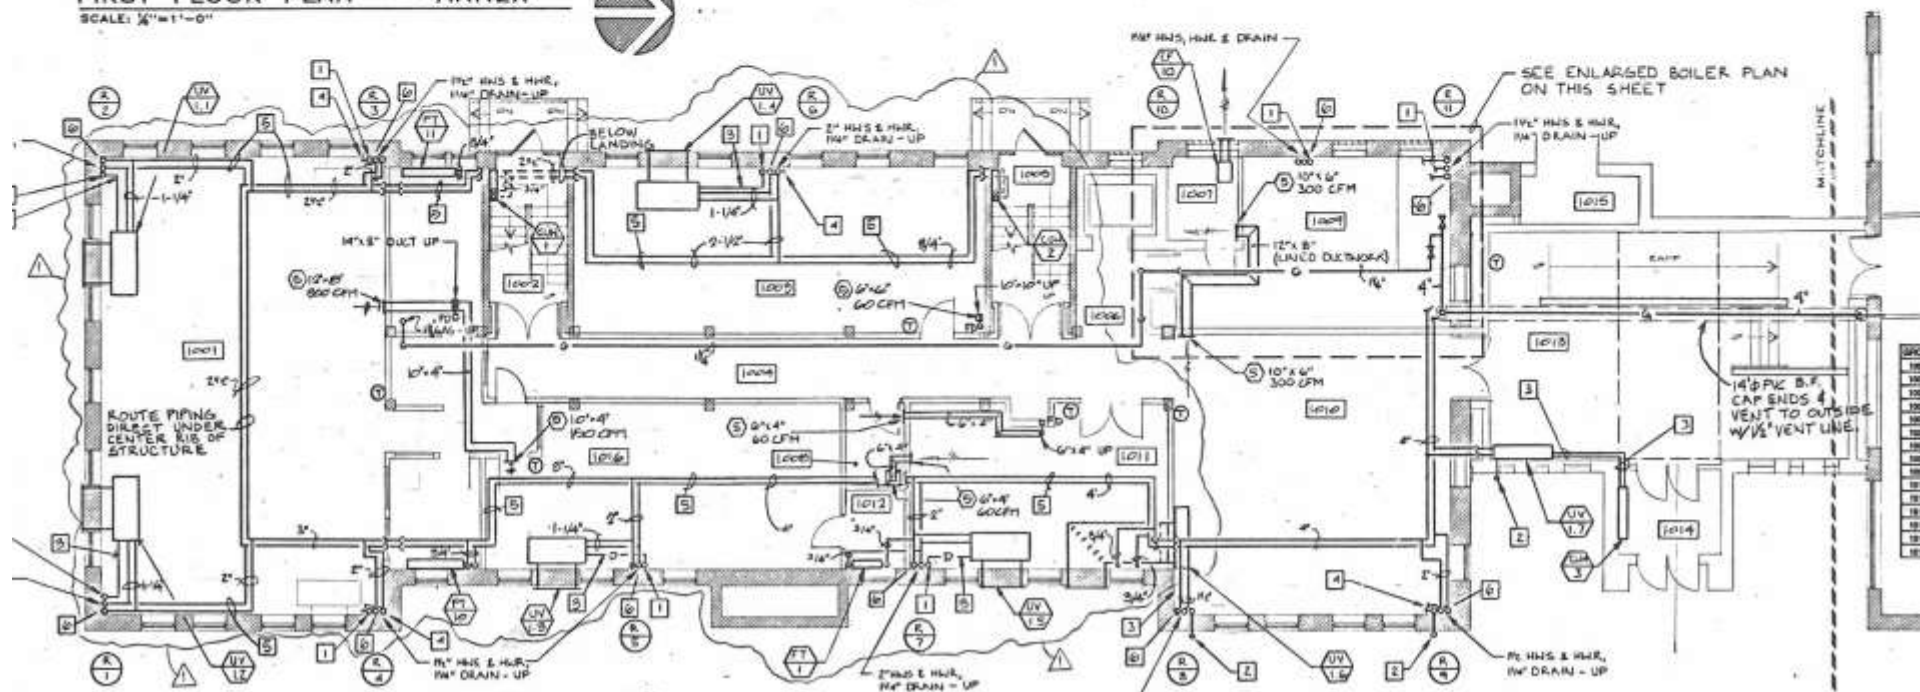

GROUND FLOOR PLAN - ANNEX

SCALE: 1/8"=1'-0"



REVISION NOTES: ANNEX BUILDING

- 1 The M.C. shall route the condensate drain line to the floor drain provided by the P.C.

PT 1 shall route the condensate drain line through the wall 12\"/>

1101
1102
1103
1104
1105
1106
1107
1108
1109
1110
1111
1112
1113
1114

1001
1002
1003
1004
1005
1006
1007
1008
1009
1010
1011
1012
1013
1014

ENCLOSURE SEE

